


REVISIONS	BY



PROGRESSIVE
DESIGNS

243 N. MAPLE AVENUE, STE B
POST OFFICE BOX 477
MANTECA, CALIFORNIA 95336
P: 209.239.1229 / F: 209.239.4880

NEW FLOOR PLAN AND NEW PLUMBING PLAN
 TENANT IMPROVEMENT FOR ABANDONED CAT TEAM
 327 E. ALPINE AVE.


DATE	06 JUL 09
SCALE	1/4" = 1'-0"
JOB	446-01-08

A2

FLOOR: Abandoned Cat Team / A2_NewFloorPlan

DRAWN: ML, JMS


24 x 36

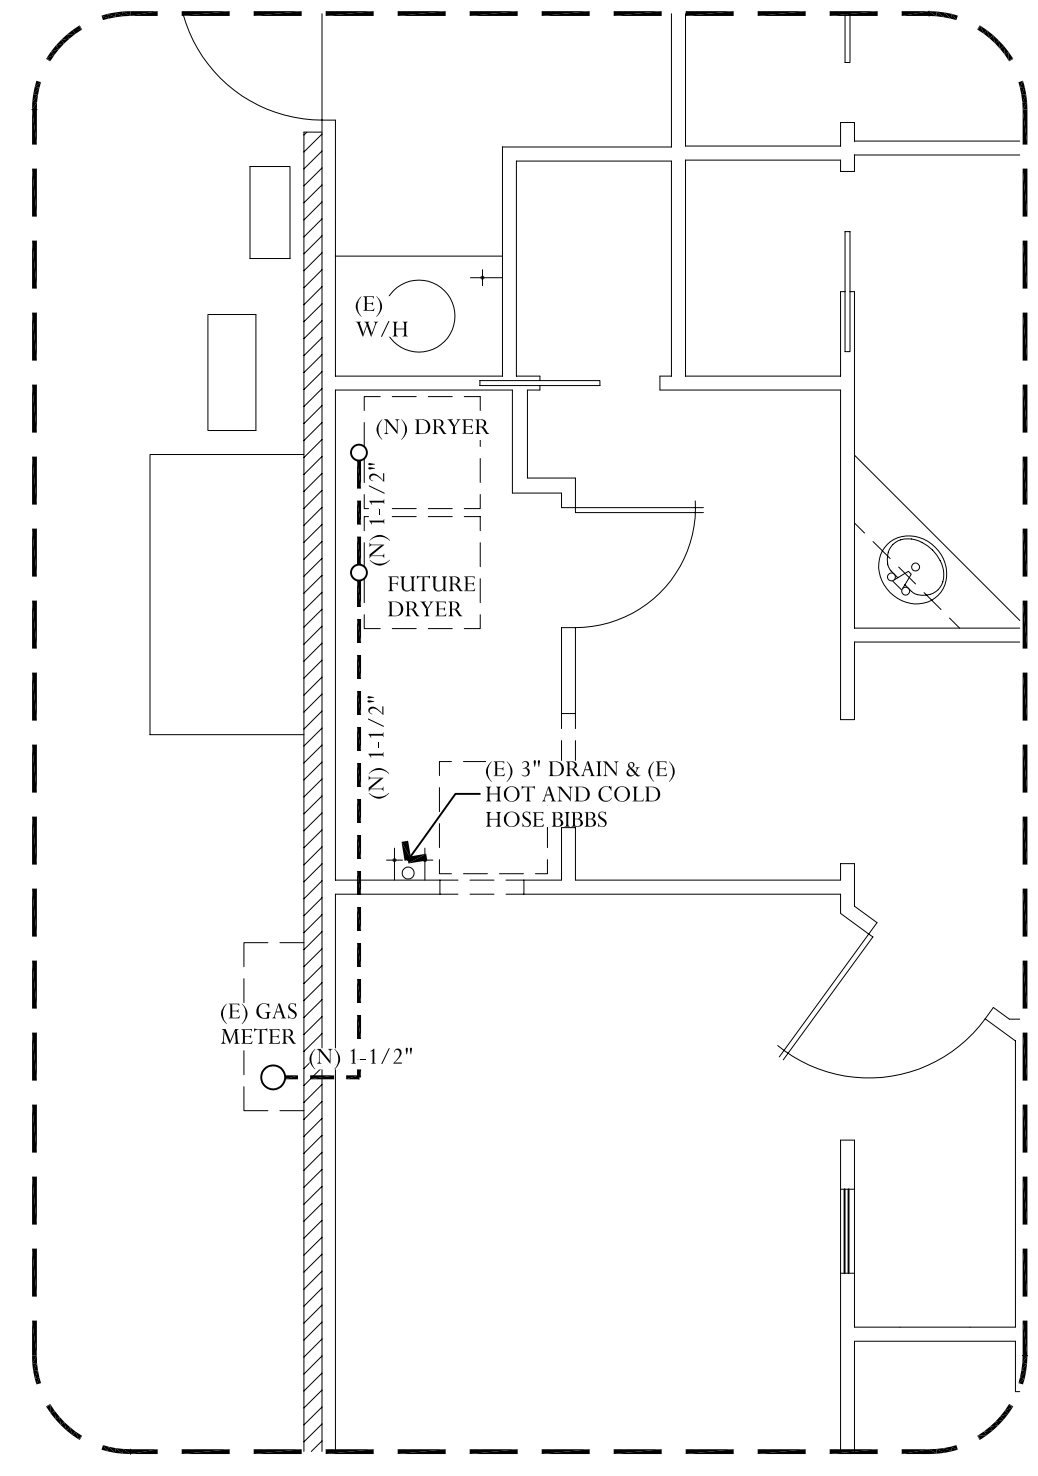

- NOTES:**
1. OXYGEN TANKS TO BE "H" SIZE, 251 CF PER TANK
 2. OXYGEN TANKS WILL BE CHAINED TO THE WALL 1/3 OF THE WAY FROM TOP OF TANK.
 3. OXYGEN TANKS WILL SIT ON A NON-SLIP RUBBER MAT.
 4. 5/16 X 3" LAG SCREW WITH WASHER TO WALL STUD FOR CHAIN HOOK UP.

NOTE:
CONTRACTOR TO VERIFY ALL EXISTING CONDITIONS PRIOR TO COMMENCEMENT OF ANY CONSTRUCTION

LEGEND	
	EXISTING 2x STUD WALL TO REMAIN
	NEW 2x STUD WALL
(E)	EXISTING TO REMAIN
(R)	EXISTING RELOCATED
(N)	NEW

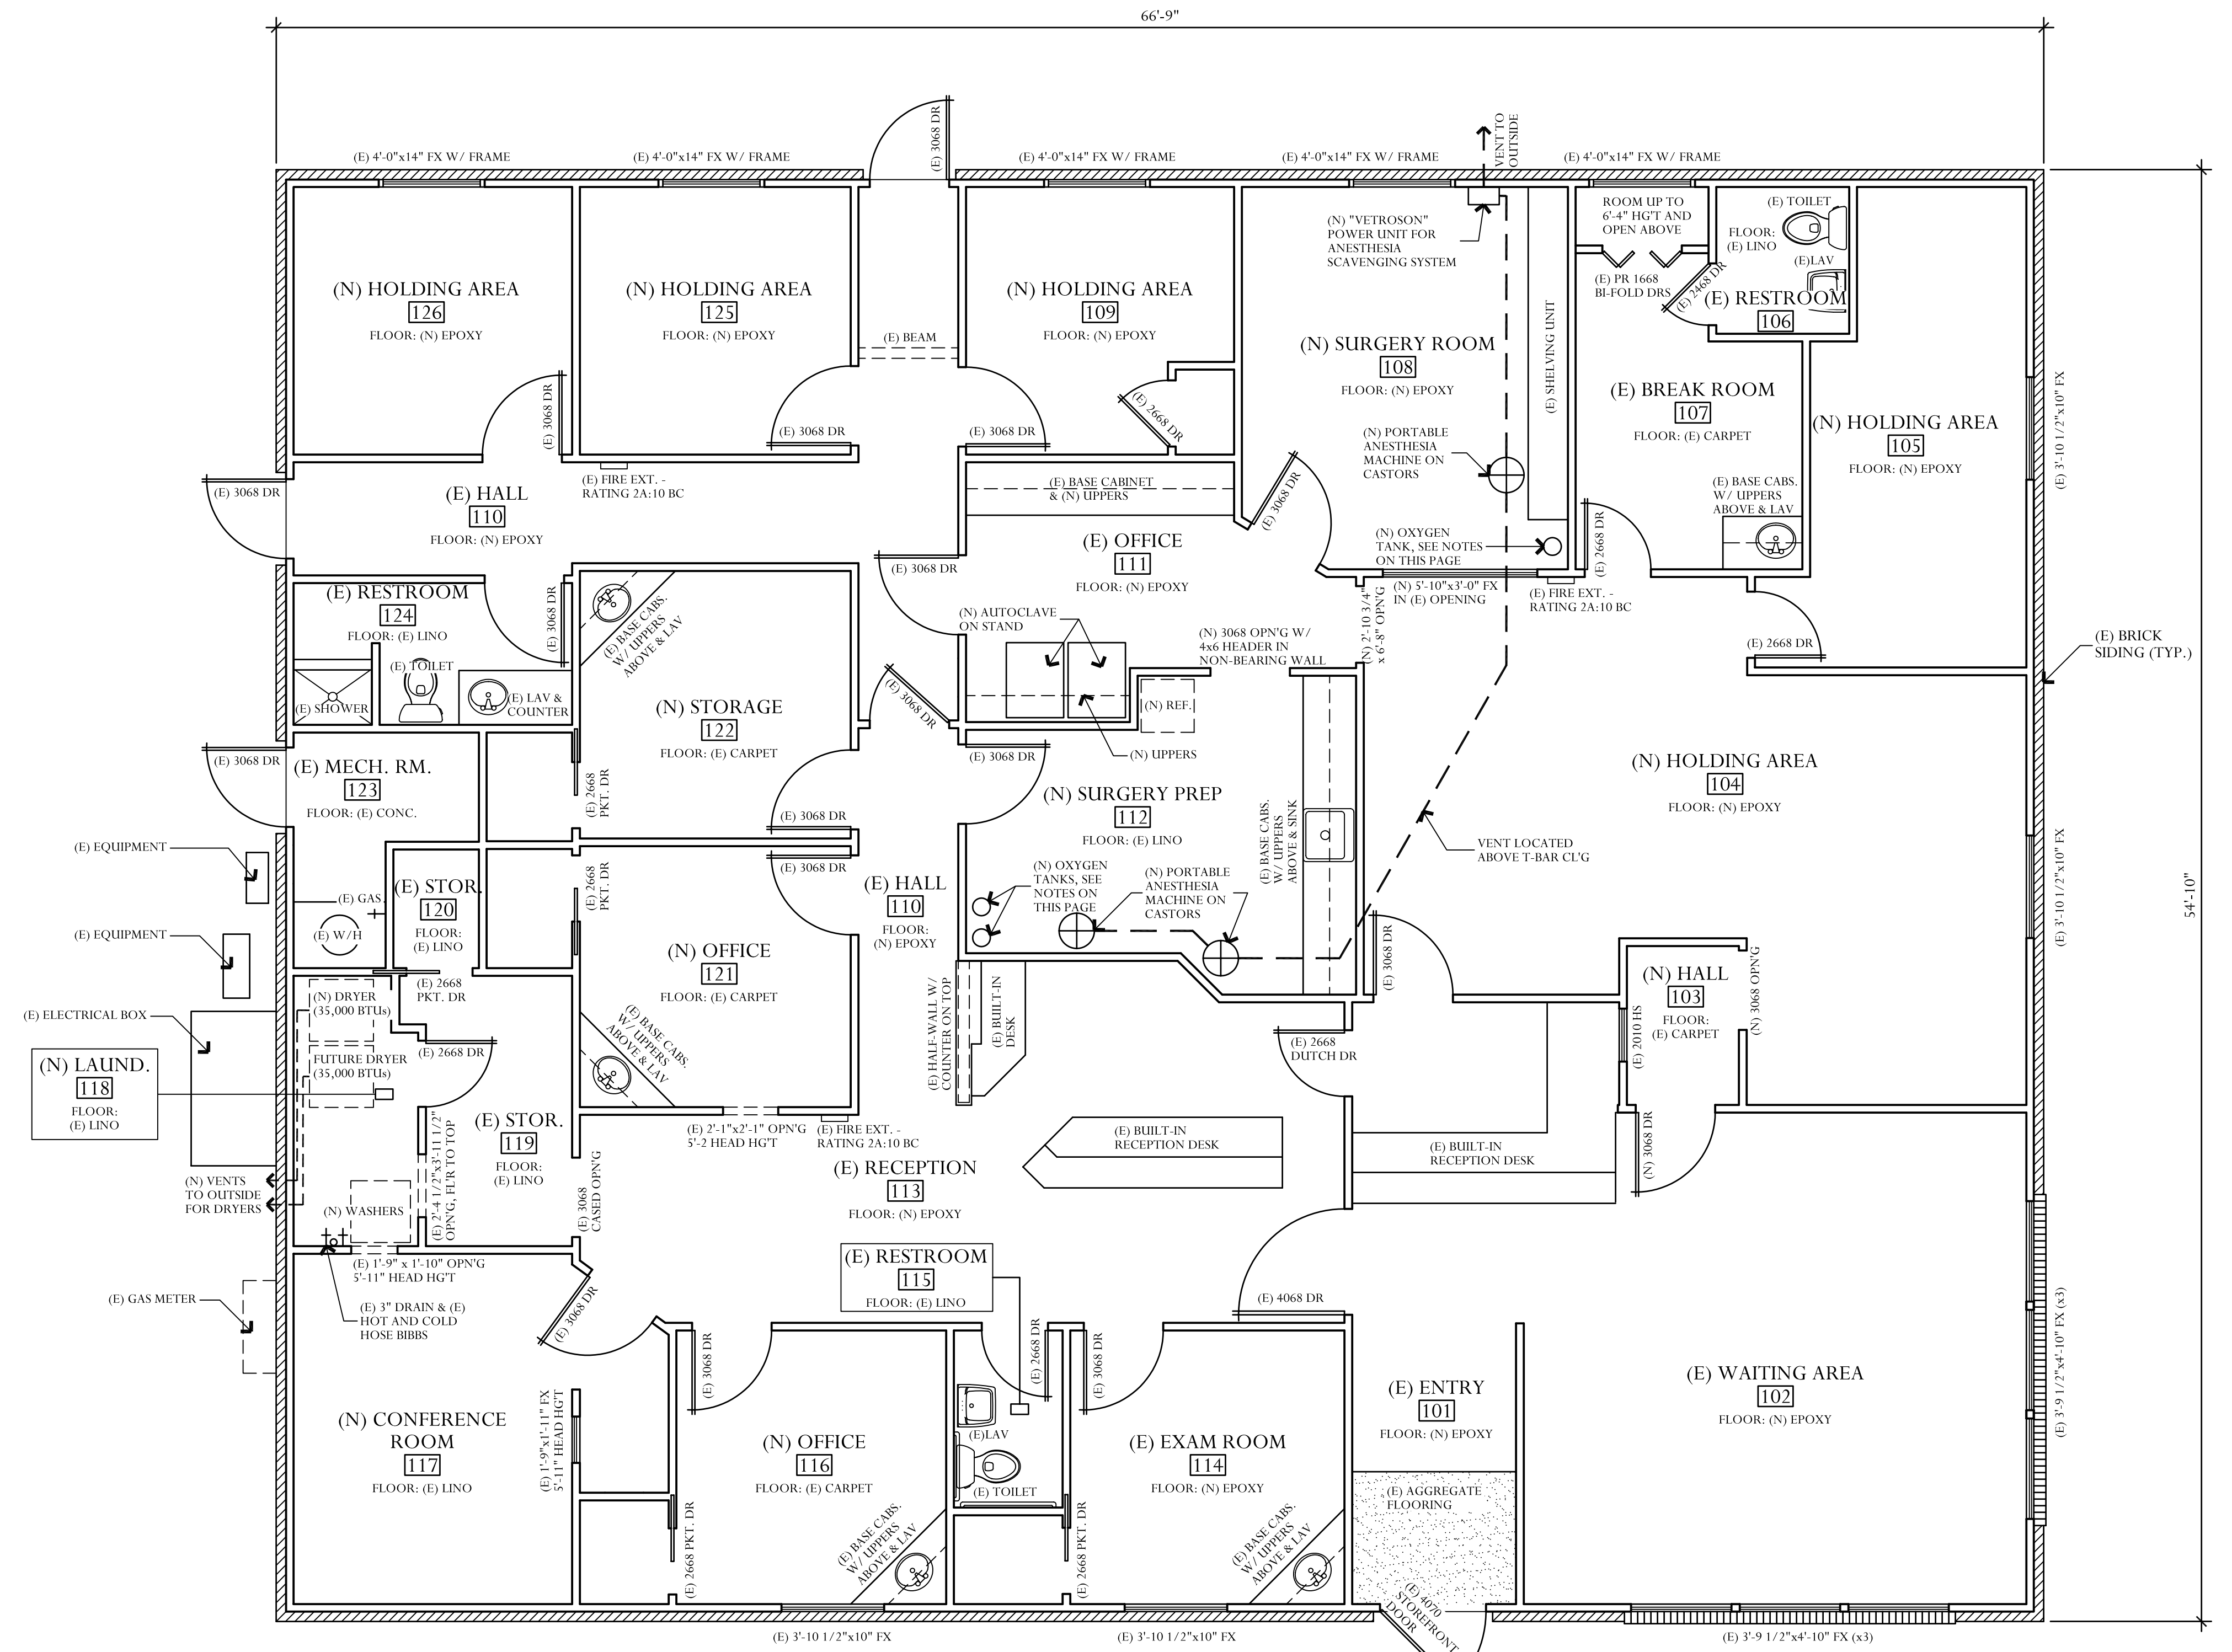

THESE PLANS AND DRAWINGS ARE NOT TO BE REPRODUCED, CHANGED, OR COPIED IN ANY FORM OR MANNER WHATSOEVER WITHOUT FIRST OBTAINING THE EXPRESS WRITTEN PERMISSION OR CONSENT OF PROGRESSIVE DESIGNS. DO NOT MAKE ANY CHANGES UNLESS UNDER ANY CIRCUMSTANCES.